
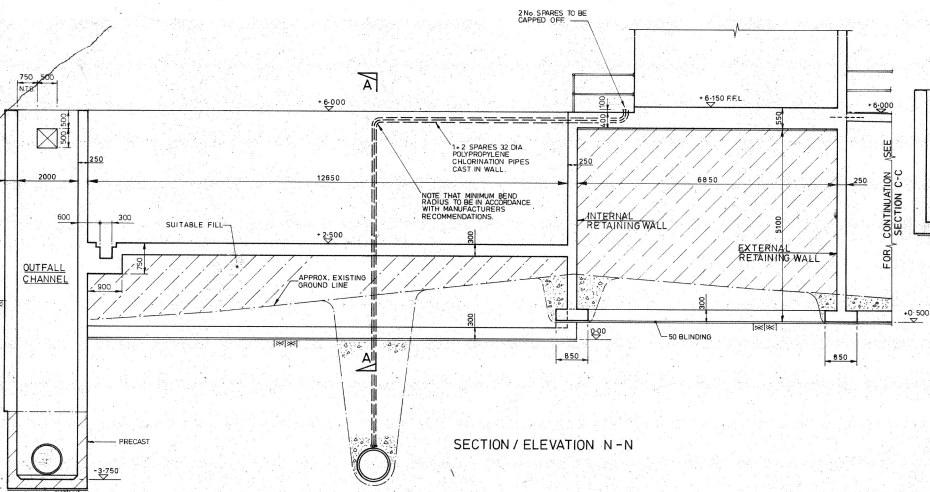
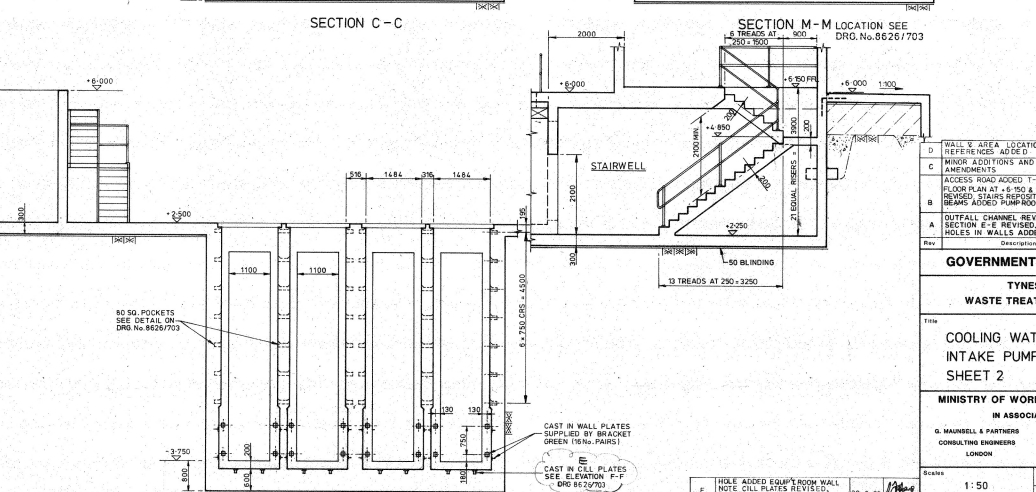
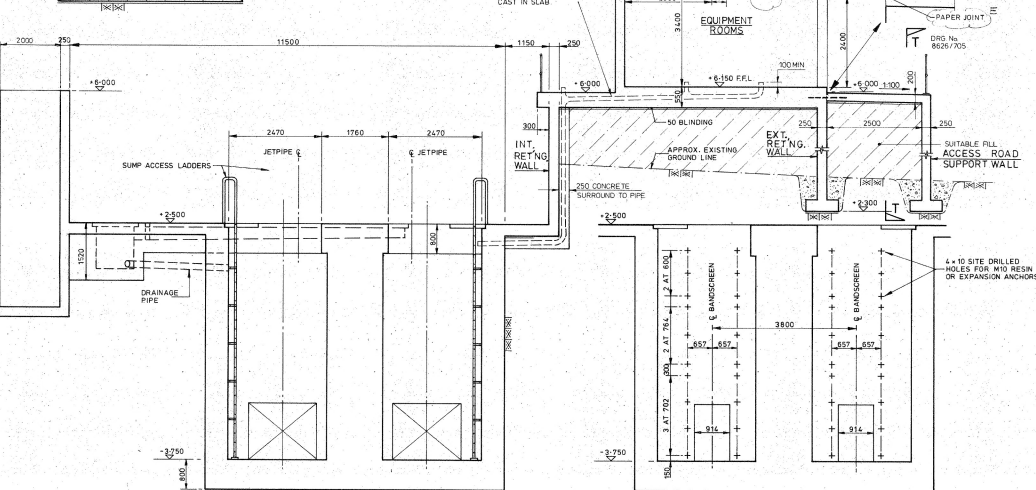
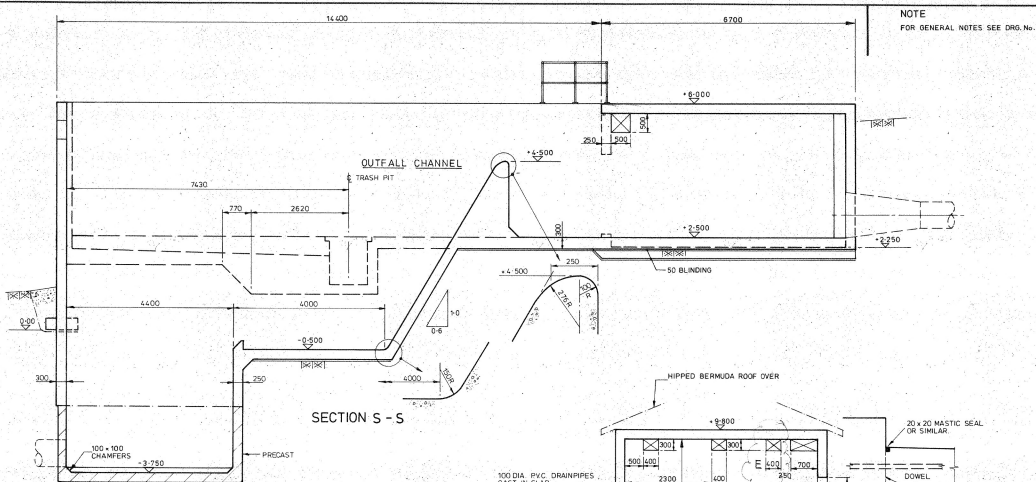


NOTE
FOR GENERAL NOTES SEE DRG. NO. 8626/705 SHEET 3

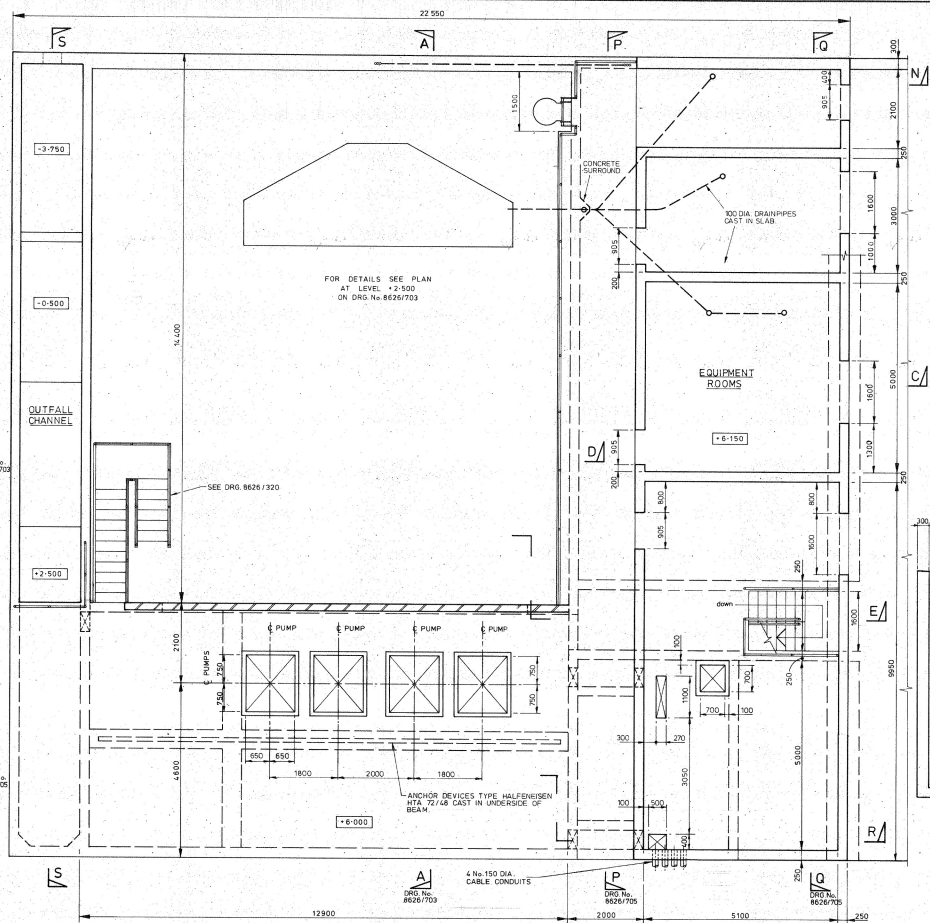

D	WALL & AREA LOCATION REFERENCES ADDED	7-4-93	
C	MINOR ADDITIONS AND AMENDMENTS	17-3-93	
B	ACCESS ROAD ADDED T-T FLOOR PLAN AT +6.150 & SEA WALL REVISED, STAIRS REPOSITIONED, BEAMS ADDED PUMP ROOM ROOF	25-2-93	
A	OUTFALL CHANNEL REVISED	12-12-92	
Rev	Description	Date	Checked

GOVERNMENT OF BERMUDA

TYNES BAY WASTE TREATMENT FACILITY

COOLING WATER SYSTEM INTAKE PUMPHOUSE G.A. SHEET 2

MINISTRY OF WORKS & ENGINEERING

IN ASSOCIATION WITH

G. MARSHALL & PARTNERS
CONSULTING ENGINEERS
LONDON

KENNEDY & DOBSON
CONSULTING ENGINEERS
MANCHESTER

WORKING DRAWING

PROJECT ENGINEER: [Signature]

PROJECT SUPERVISOR: [Signature]

Scale: 1:50

Date: DEC 1992

Drawn: [Signature]

Checked: [Signature]

Approved: [Signature]

Revision: E